




PROPOSED GROUND FLOOR PLAN
1:100

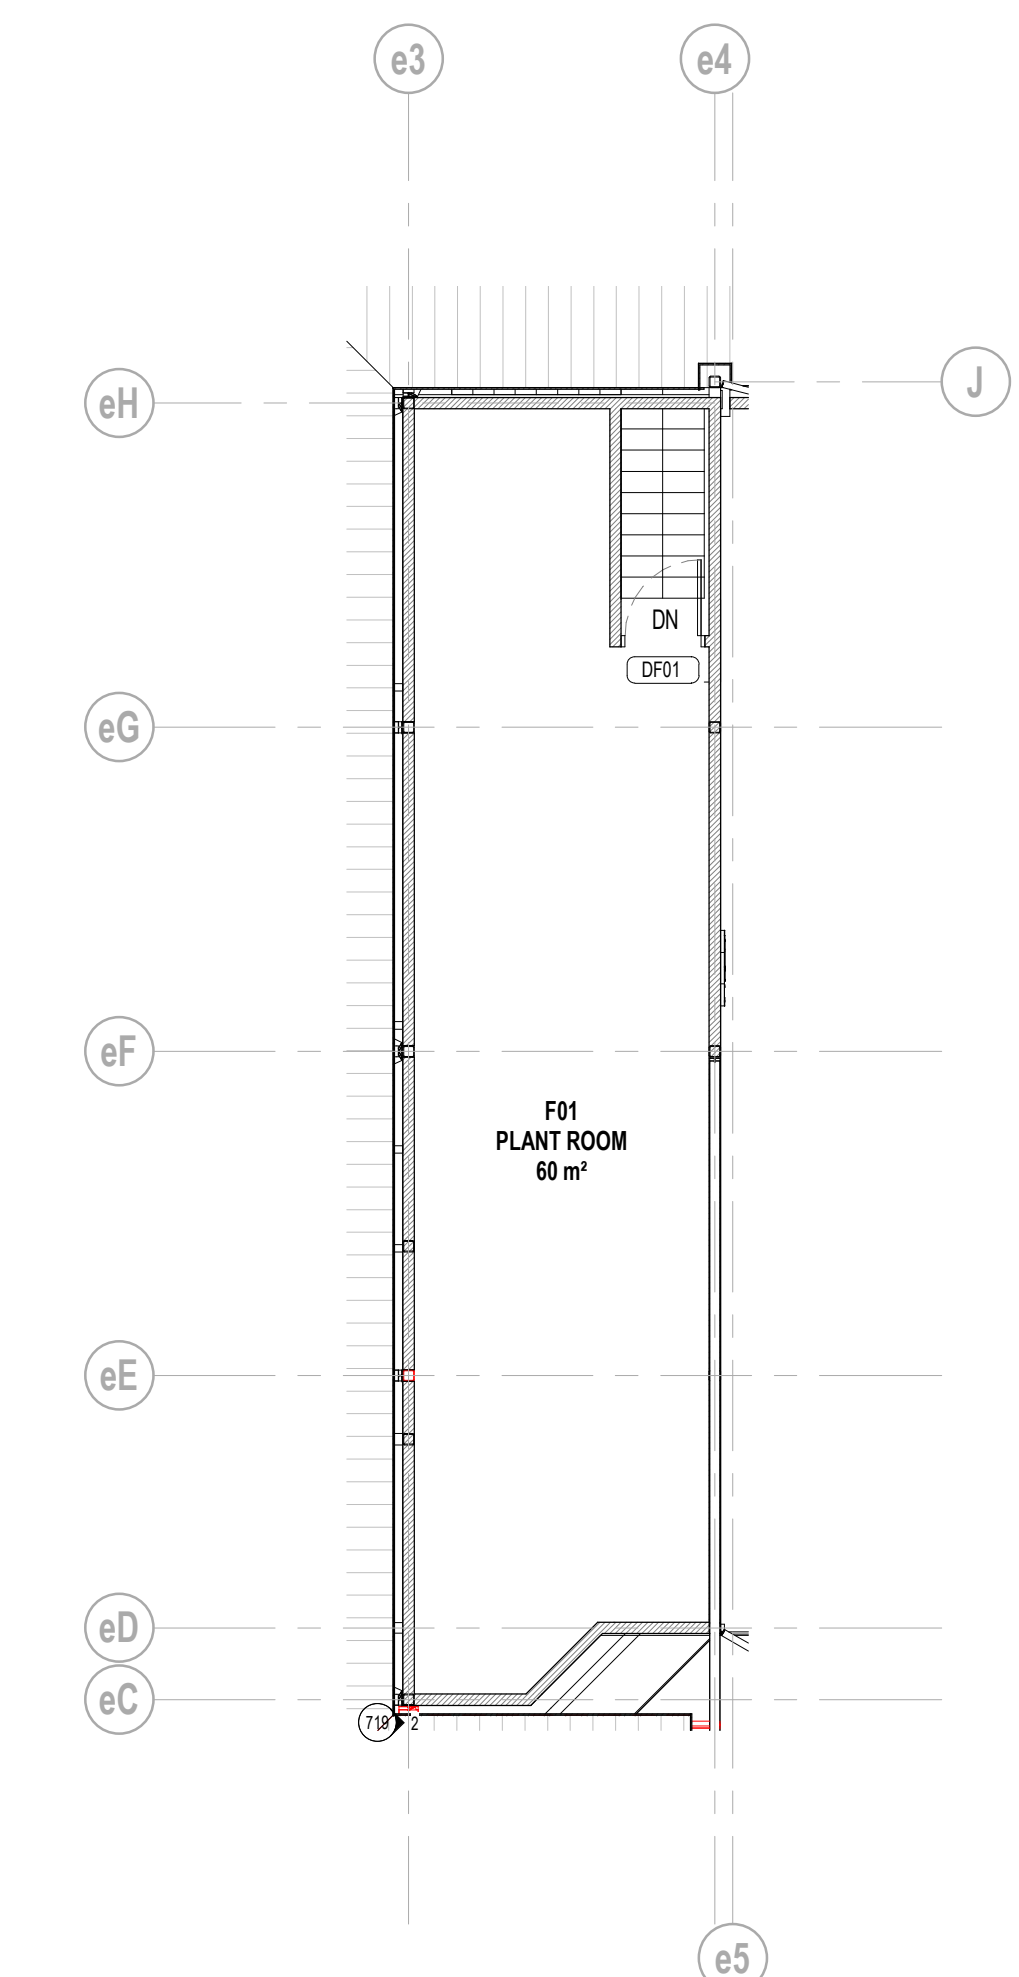

PROPOSED FIRST FLOOR PLAN
1:100

status **PRELIMINARY**

This drawing is © Bradshaw Gass & Hope LLP and is not to be copied, reproduced or re-distributed either in whole or in part without the prior written permission of the originator.
The originator shall have no responsibility for any liability, loss, cost, damage or expense arising from or relating to any use of this document other than for its intended purpose on this project.
This drawing shall be read in conjunction with all other relevant drawings, specifications and associated documentation. Any discrepancies, errors or omissions are to be reported to the originator before proceeding with work.
All dimensions are to be checked on site by the contractor prior to proceeding with any work.

Hazard Identification		
ref	hazard	date

ROLLER SHUTTER:
ROLLER SHUTTER TO BE PROVIDED IN SECTIONAL WIDTHS AS PER MANUFACTURERS RECOMMENDATIONS.

P4	UPDATED HYGIENEWC LAYOUT, UPDATED POINT OF SALE GOODS DISPLAY, TV LOCATIONS ADDED, ROLLER SHUTTER NOTE ADDED.	DB	26.02.20
P3	CLIENT COMMENTS INCORPORATED	DB	17.01.20
P2	CLIENT COMMENTS INCORPORATED	DB	05.12.19
ref	revision	by	date

BGH Architects
Consulting Engineers
Quantity Surveyors
21 Silverwell Street
Bolton
BL1 1PR
t: 01204 525321
email@bghbolton.co.uk
www.bghbolton.co.uk

Bradshaw Gass & Hope LLP

client
ALLIANCE LEISURE

project
**NORTHFIELD SWIMMING POOL,
KETTLEHILLS CRESCENT,
ABERDEEN**

drawing
PROPOSED FLOOR PLANS

drawn by	DB	date	NOV 2019
checked by	CP	date	NOV 2019
scale	1:100		A1
dwg no	2158.19.303	rev	P4

